
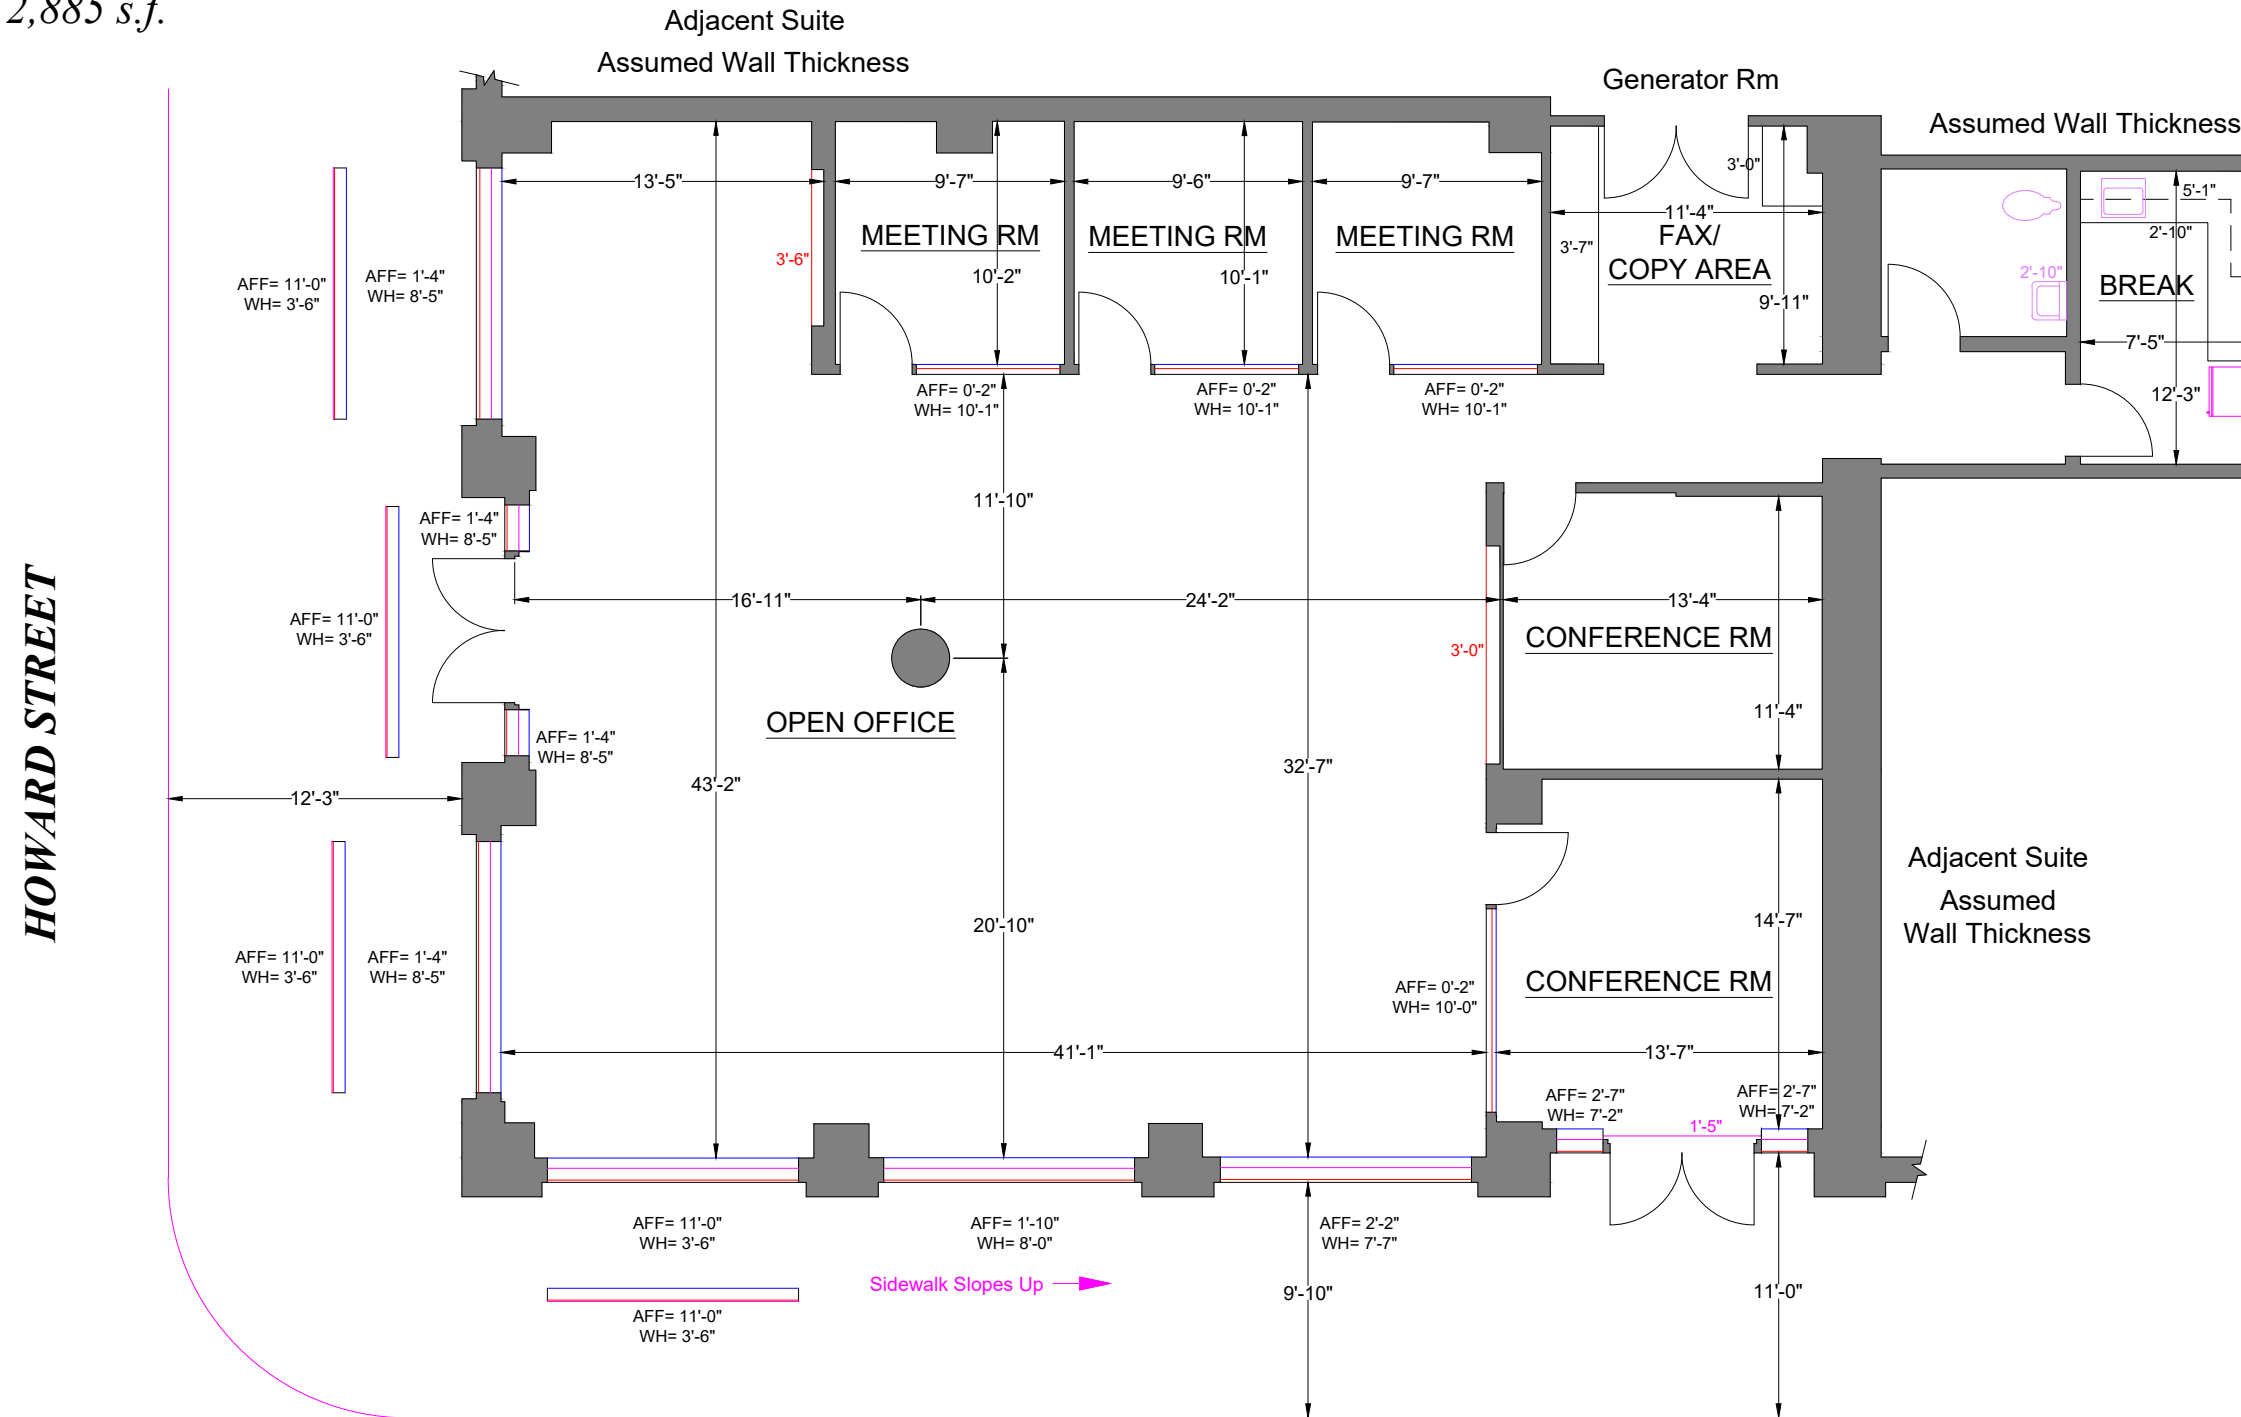


**FLOOR PLAN**

\*Measured Area: 2,885 s.f.

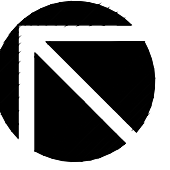

ELEVATION LEGEND	
Spot Height (Above Finished Floor):	+ X'-X"
Sill Height (Above Finished Floor):	AFF= X'-X"
Window Height:	WH= X'-X"
Survey Accuracy: +/- 0.05 %	

**Note:** All dimensions shown are rounded to the nearest inch, for informational purposes only. All measurements are recorded to 1/8" accuracy as documented in the final CAD drawing supplied.

**HAWTHORNE STREET**



SCALE: 1/8" = 1' -0"


LASERTECH® is a registered US trademark of Lasertech® Floorplans Ltd. Copyright 1998 Lasertech® Floorplans Ltd., All Rights Reserved

\*Measured Area represents the footprint of the floor, and is used solely for billing purposes. It is NOT to be used for leasing purposes.




<https://LT-FP.com>  
 TEL: (888) 393-6655  
 FILE: 26-091

**ELECTRICAL PLAN**

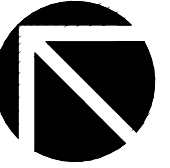

**HOWARD STREET**

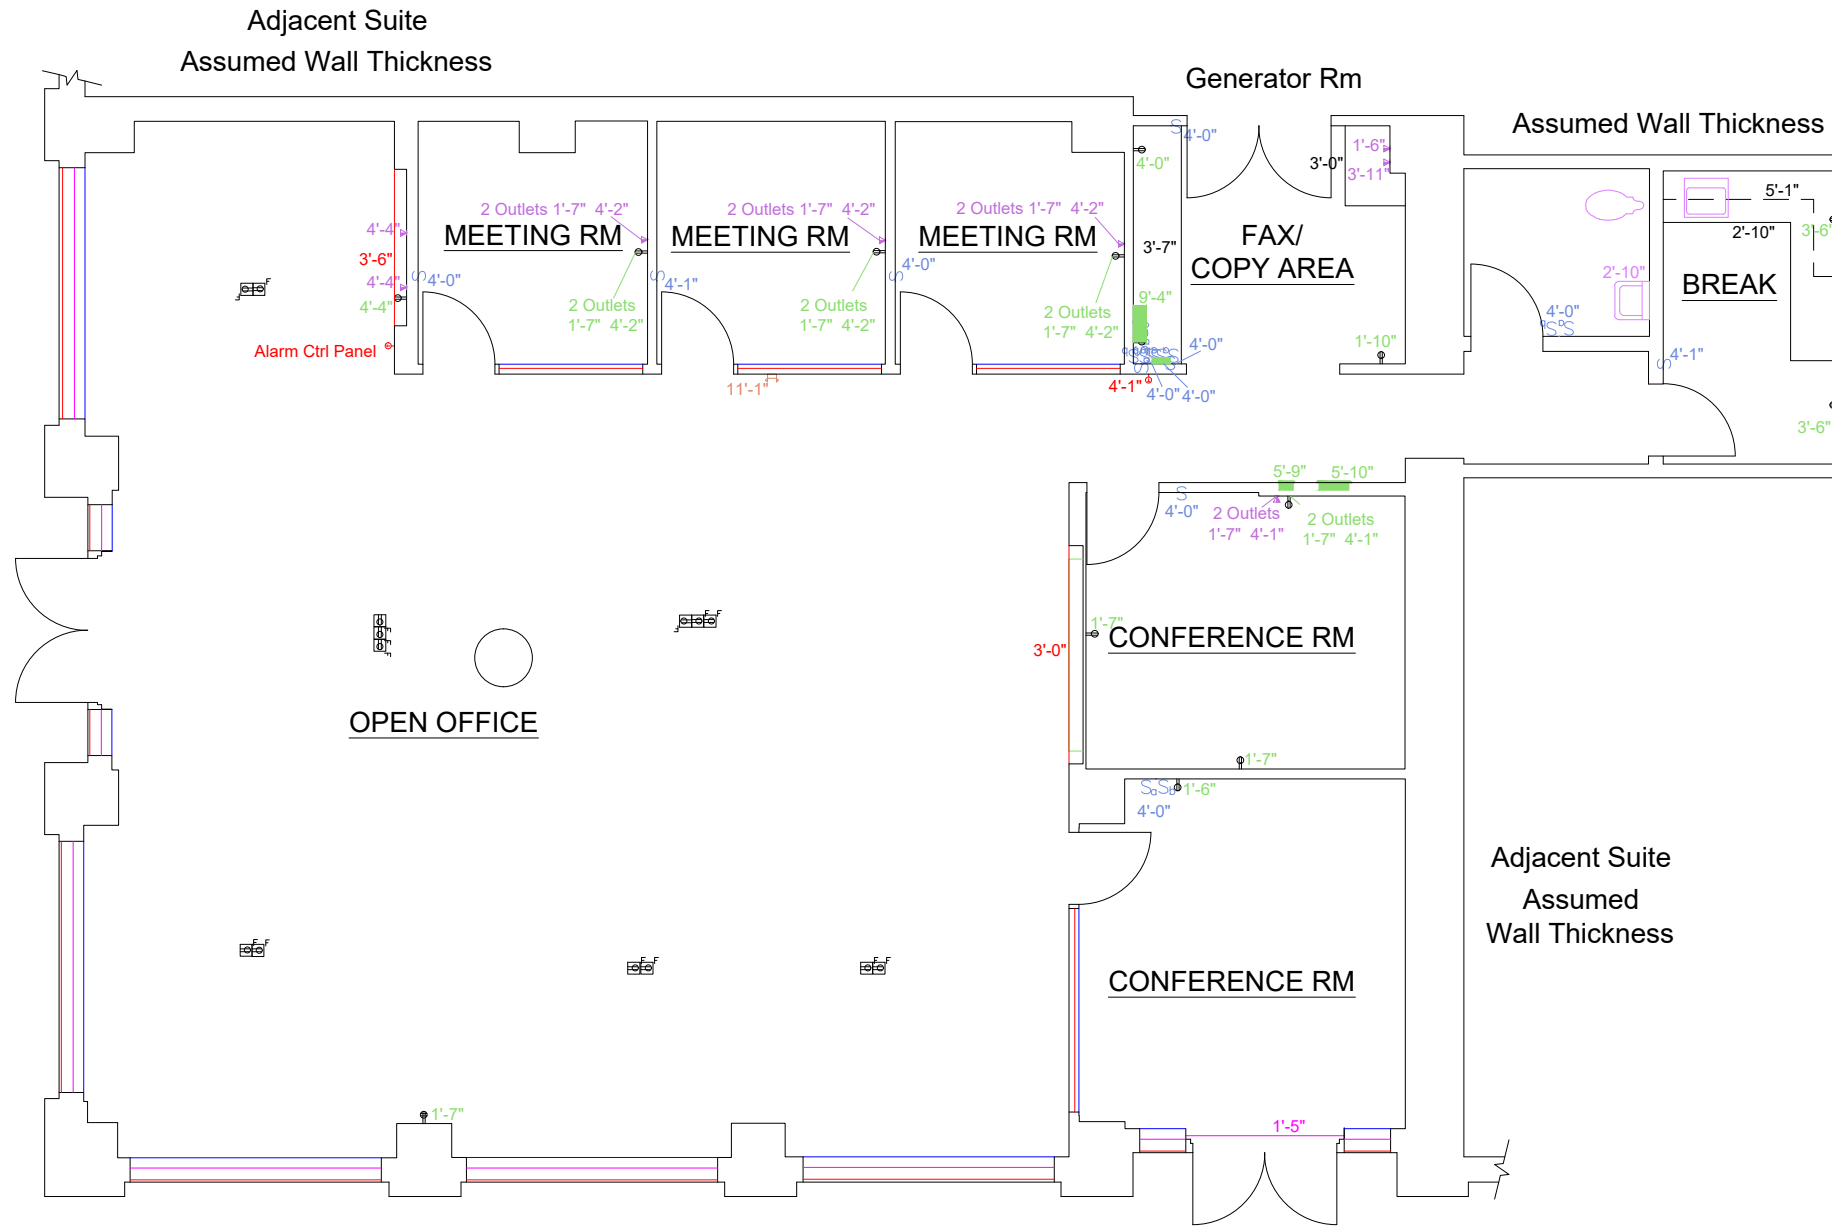

**HAWTHORNE STREET**

**ELEVATION LEGEND**

Spot Height (Above Finished Floor): + X'-X"  
 Sill Height (Above Finished Floor): AFF= X'-X"  
 Window Height: WH= X'-X"

Survey Accuracy: +/- 0.05 %



SCALE: 1/8" = 1' - 0"



LASERTECH® is a registered US trademark of Lasertech® Floorplans Ltd.  
 Copyright 1998 Lasertech® Floorplans Ltd., All Rights Reserved



<https://LT-FP.com>

TEL: (888) 393-6655  
 FILE: 26-091

**REFLECTED CEILING PLAN**

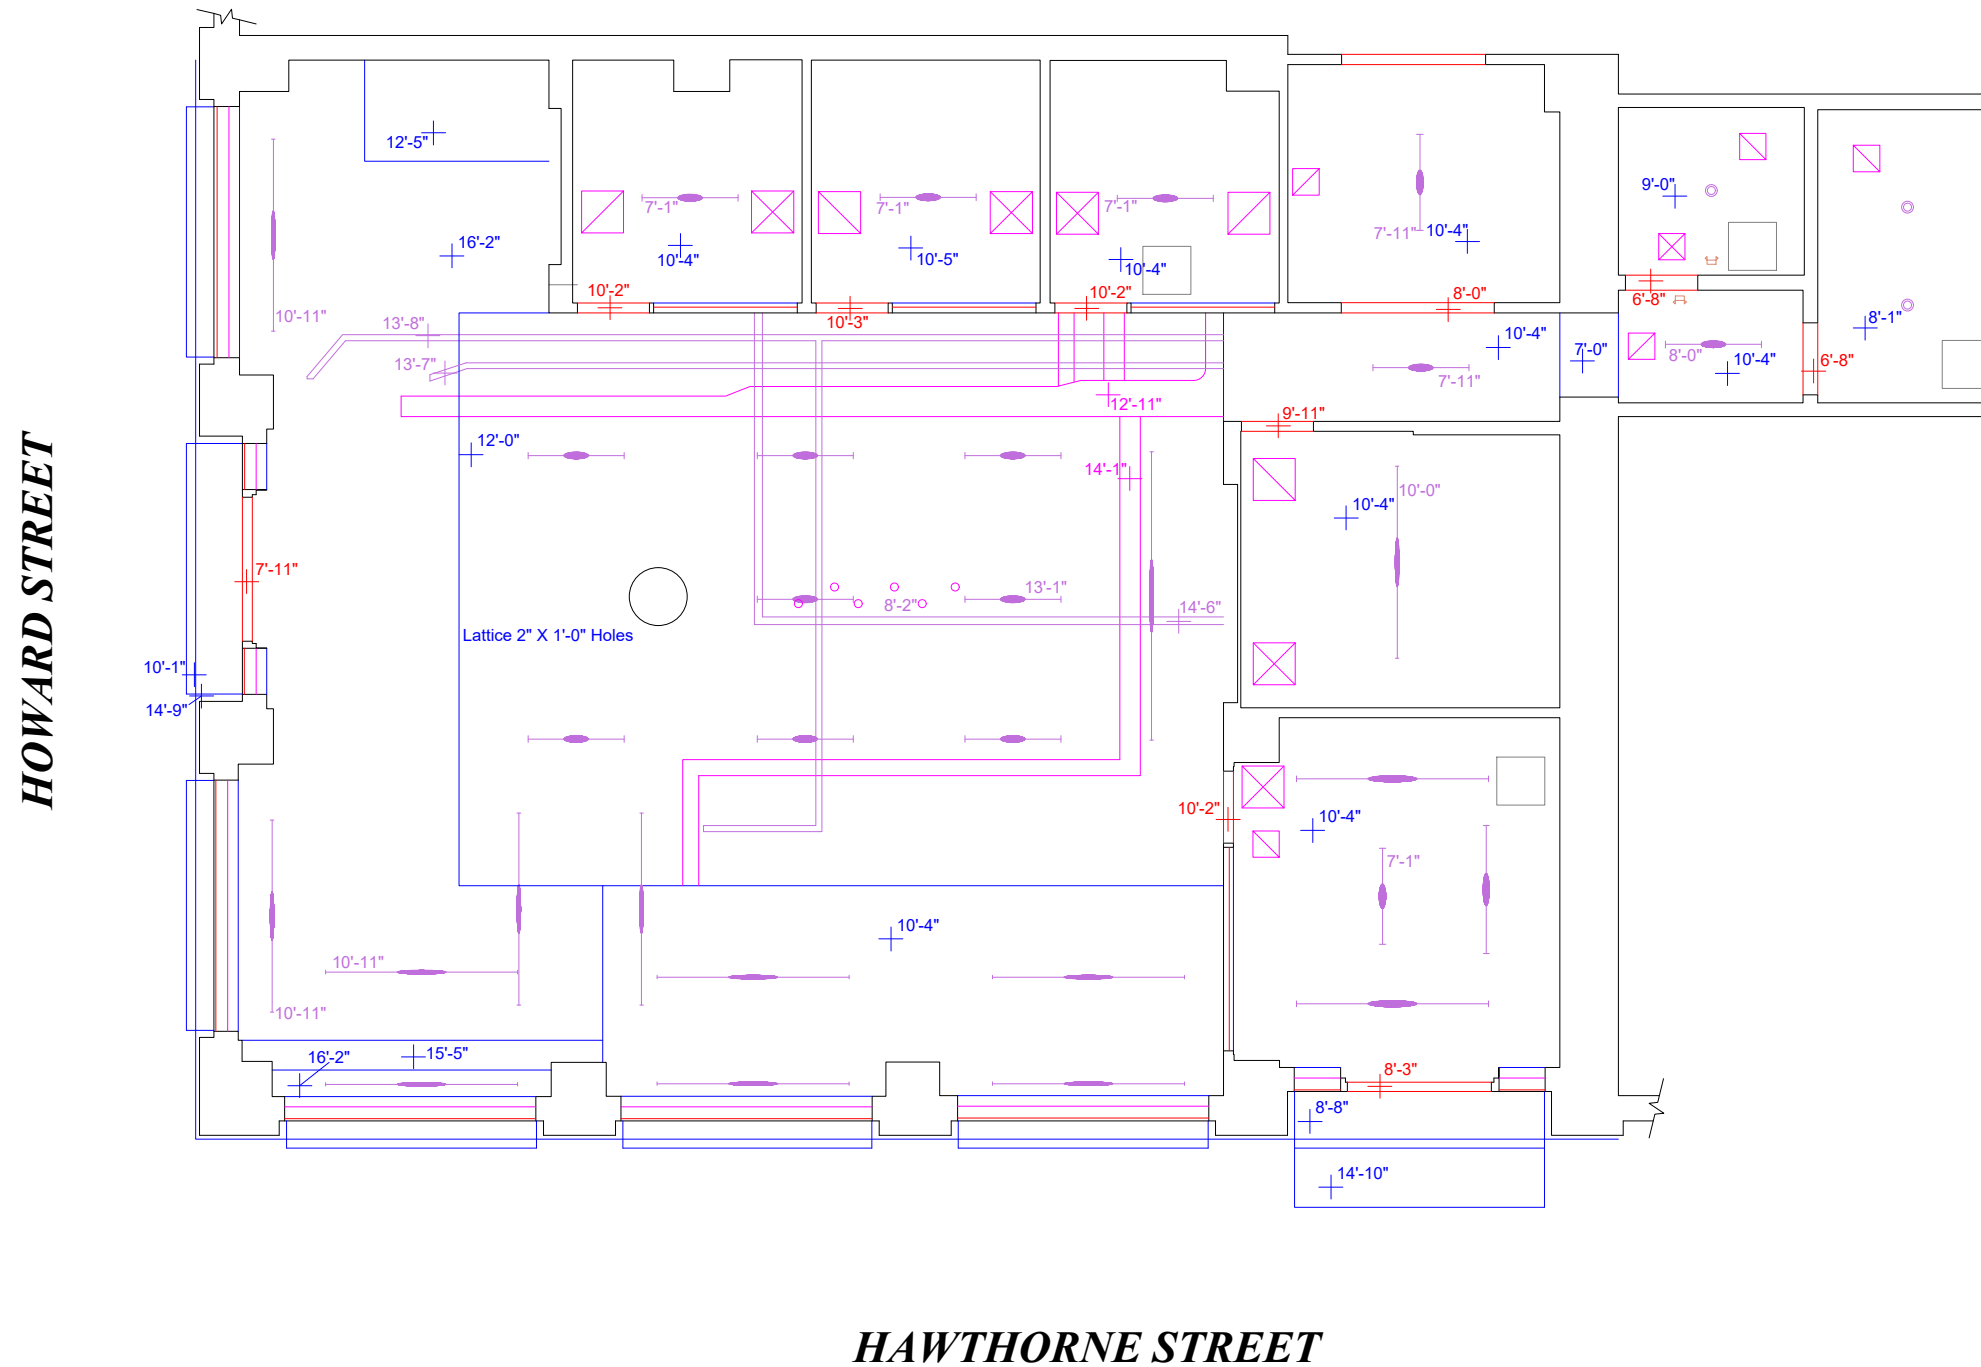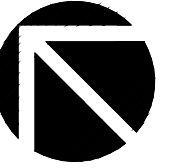

ELEVATION LEGEND	
Spot Height (Above Finished Floor):	+ X'-X"
Sill Height (Above Finished Floor):	AFF= X'-X"
Window Height:	WH= X'-X"
Survey Accuracy: +/- 0.05 %	

**HAWTHORNE STREET**





SCALE: 1/8" = 1' - 0"

LASERTECH® is a registered US trademark of Lasertech® Floorplans Ltd.  
 Copyright 1998 Lasertech® Floorplans Ltd., All Rights Reserved



<https://LT-FP.com>  
 TEL: (888) 393-6655  
 FILE: 26-091

**FIRE SAFETY PLAN**

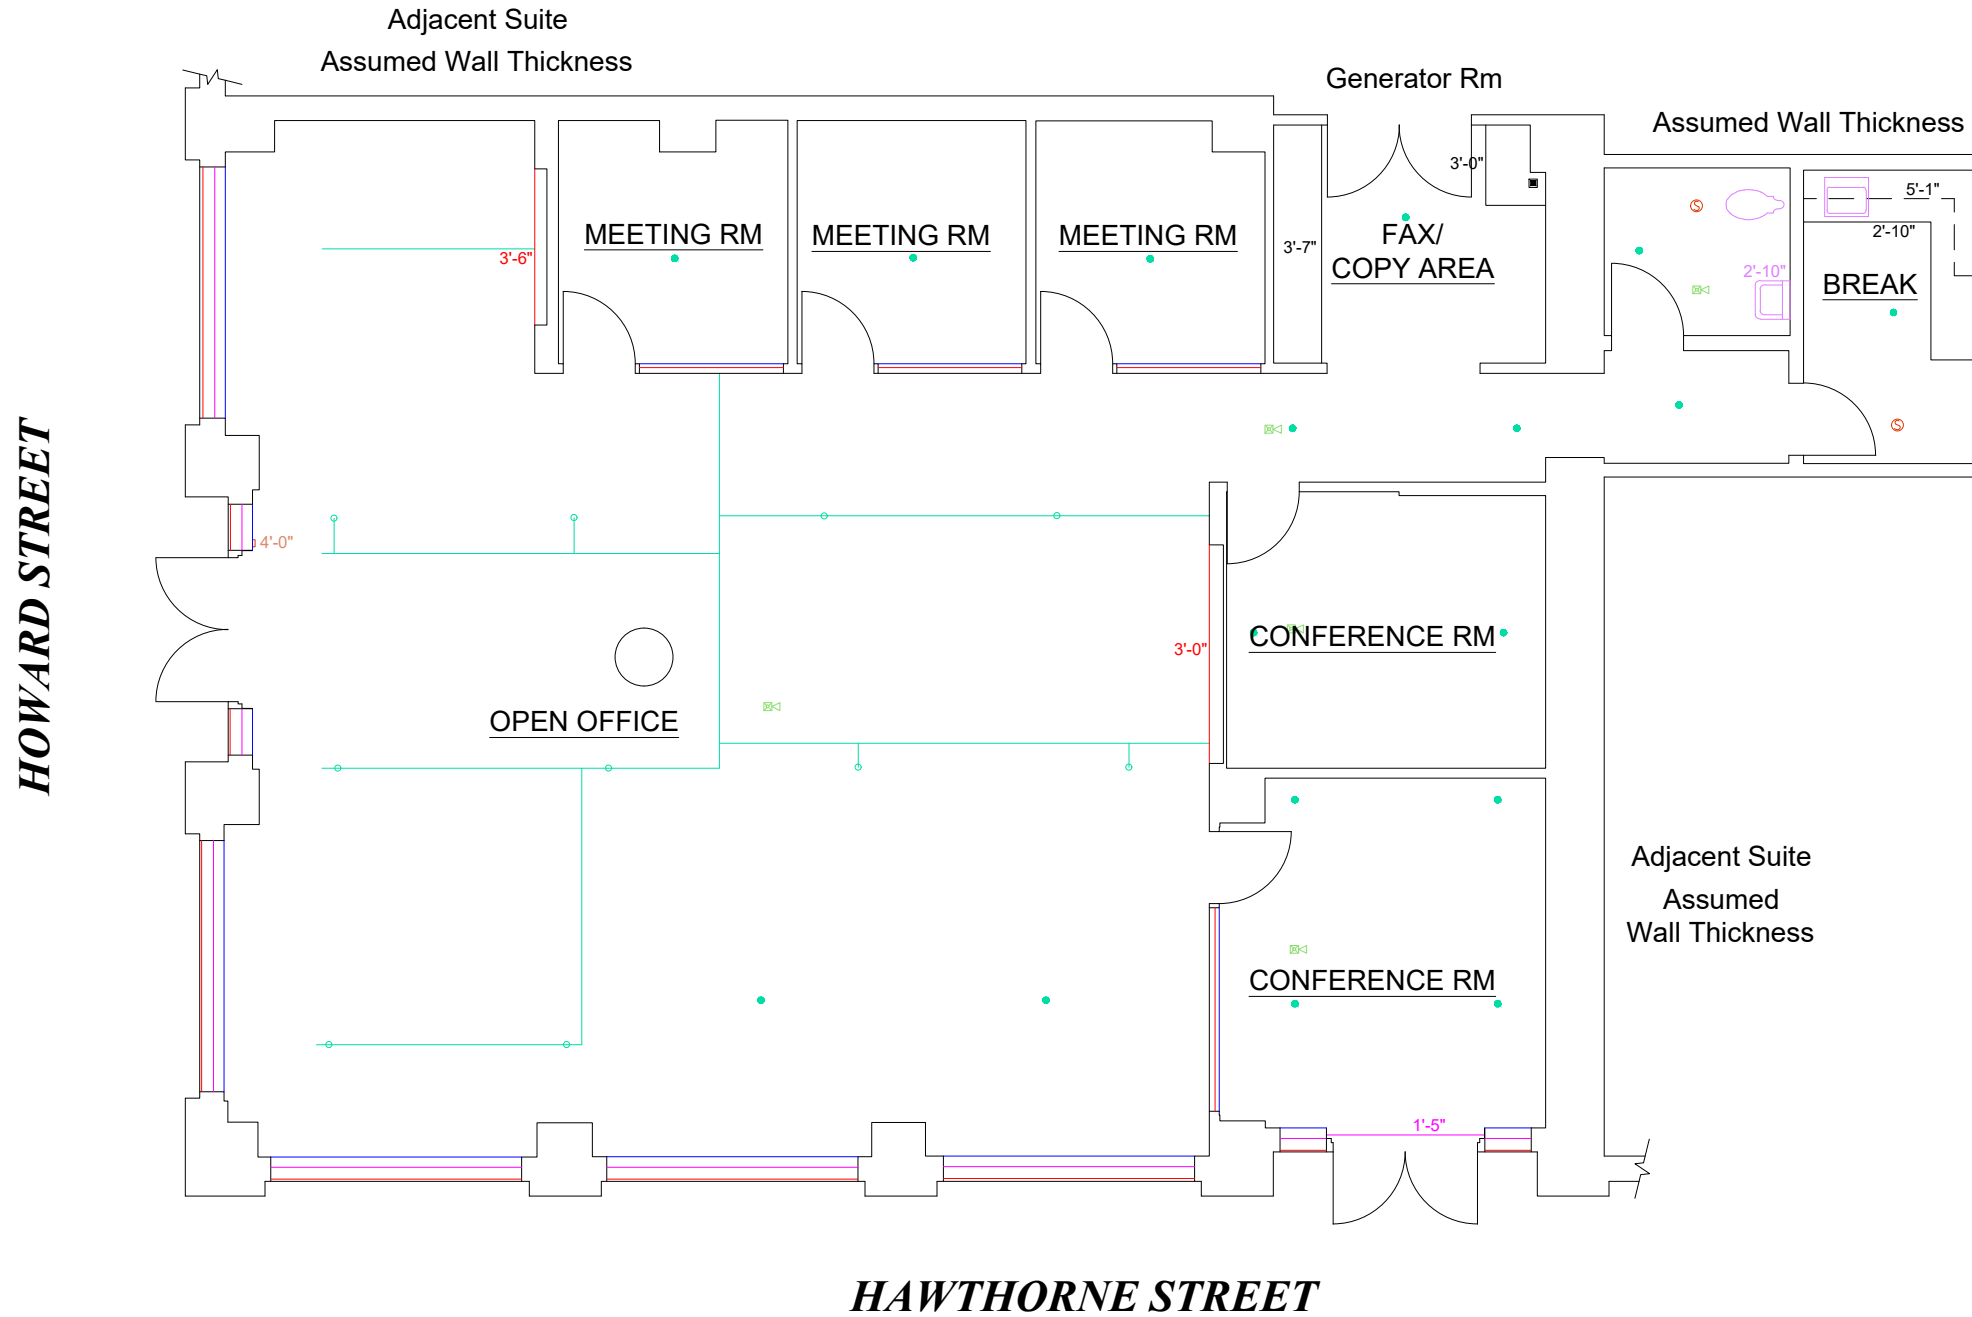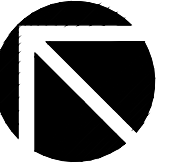

ELEVATION LEGEND	
Spot Height (Above Finished Floor):	+ X'-X"
Sill Height (Above Finished Floor):	AFF= X'-X"
Window Height:	WH= X'-X"
Survey Accuracy: +/- 0.05 %	




SCALE: 1/8" = 1' - 0"

**LASERTECH**® is a registered US trademark of Lasertech® Floorplans Ltd.  
 Copyright 1998 Lasertech® Floorplans Ltd., All Rights Reserved




<https://LT-FP.com>  
 TEL: (888) 393-6655  
 FILE: 26-091

**ROOM AREA PLAN**

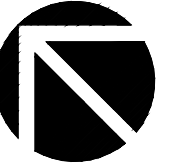

HOWARD STREET

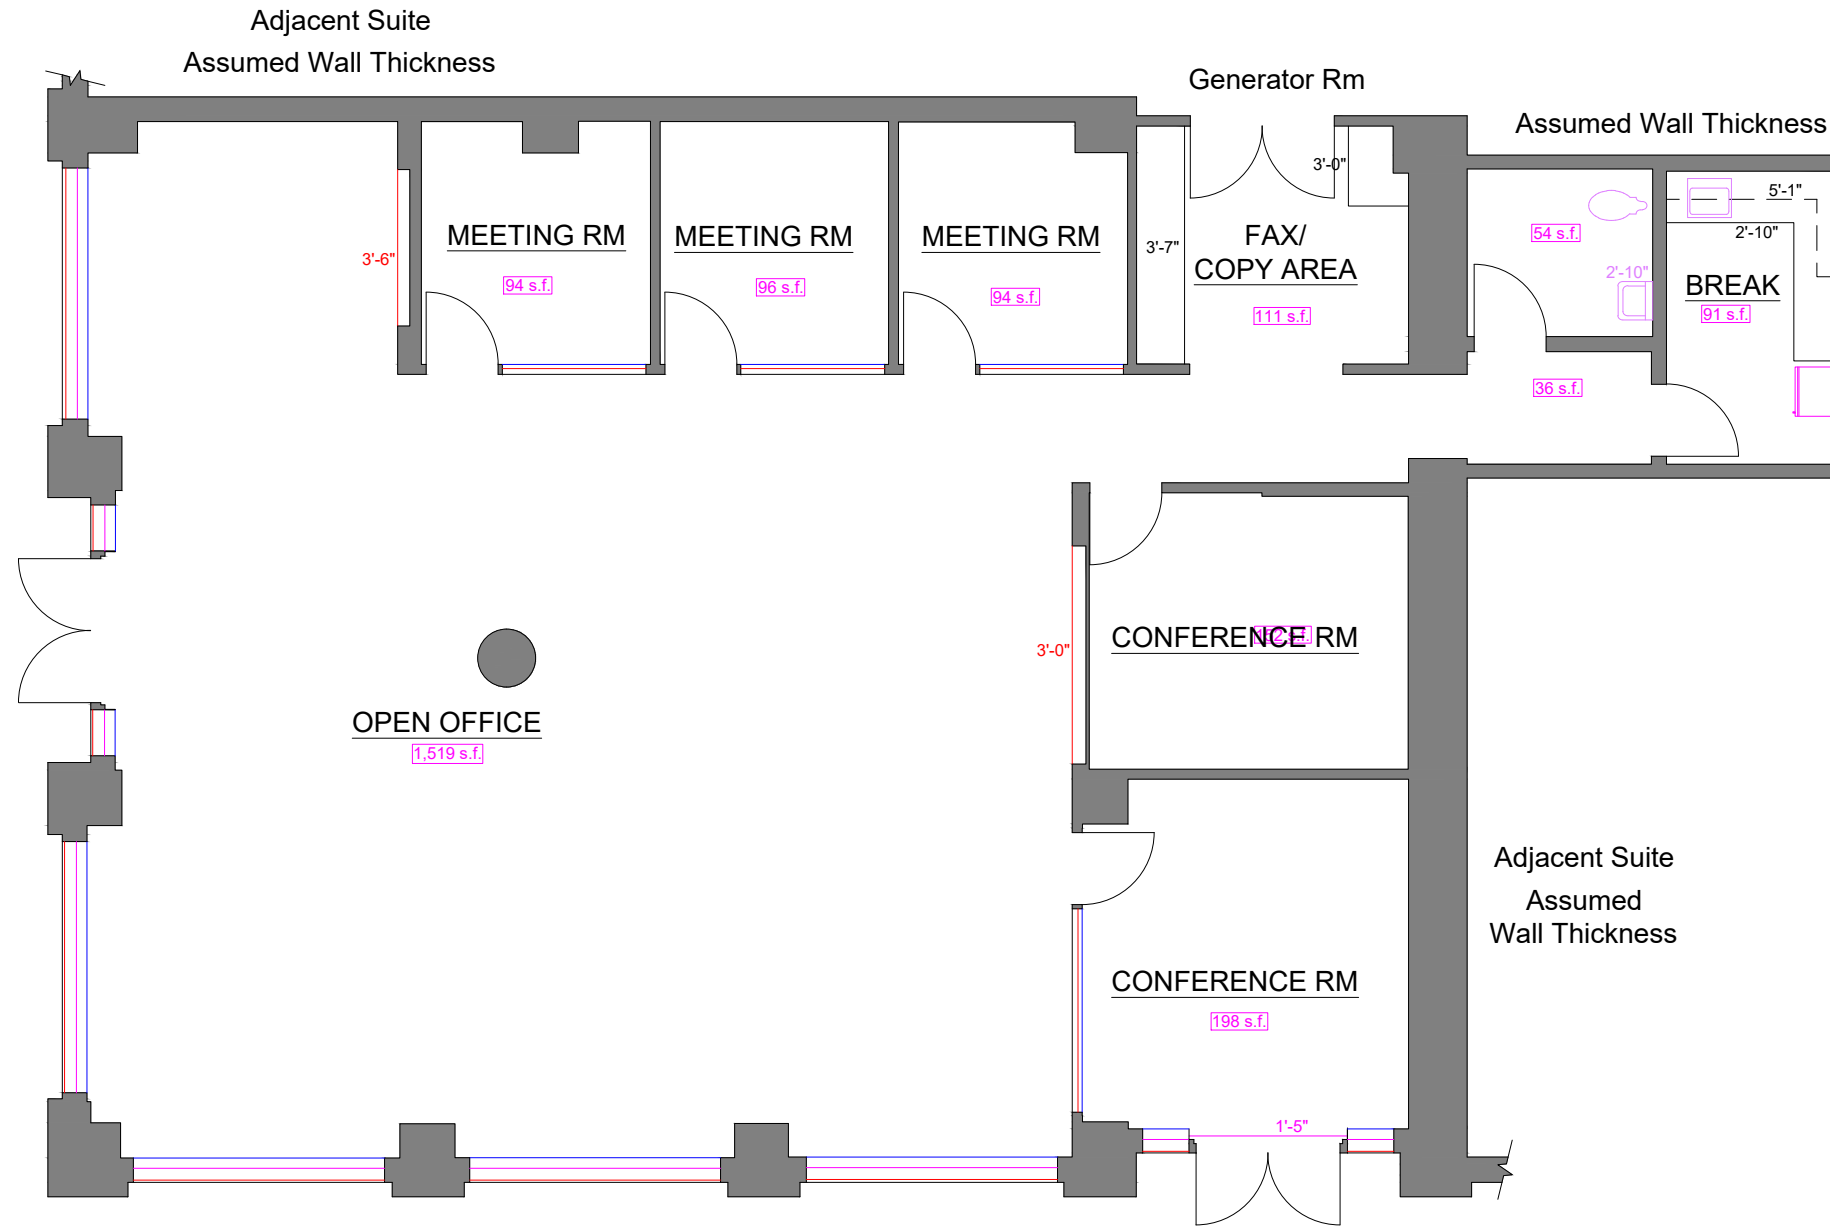

Sidewalk Slopes Up →

HAWTHORNE STREET



SCALE: 1/8" = 1' - 0"

LASERTECH® is a registered US trademark of Lasertech® Floorplans Ltd.  
 Copyright 1998 Lasertech® Floorplans Ltd., All Rights Reserved

\*Measured Area represents the footprint of the floor, and is used solely for billing purposes. It is NOT to be used for leasing purposes.


**Note:** All dimensions shown are rounded to the nearest inch, for informational purposes only. All measurements are recorded to 1/8" accuracy as documented in the final CAD drawing supplied.

Survey Accuracy: +/- 0.05 %



<https://LT-FP.com>  
 TEL: (888) 393-6655  
 FILE: 26-091

**PHOTO KEYMAP**

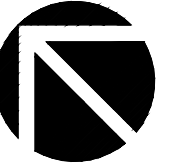

HOWARD STREET

HAWTHORNE STREET



SCALE: 1/8" = 1' - 0"

LASERTECH® is a registered US trademark of Lasertech® Floorplans Ltd.  
Copyright 1998 Lasertech® Floorplans Ltd., All Rights Reserved



<https://LT-FP.com>  
TEL: (888) 393-6655  
FILE: 26-091




# EVACUATION PLAN

## 645 HOWARD ST

**1** st Floor

**EMERGENCY PHONE #: 911**

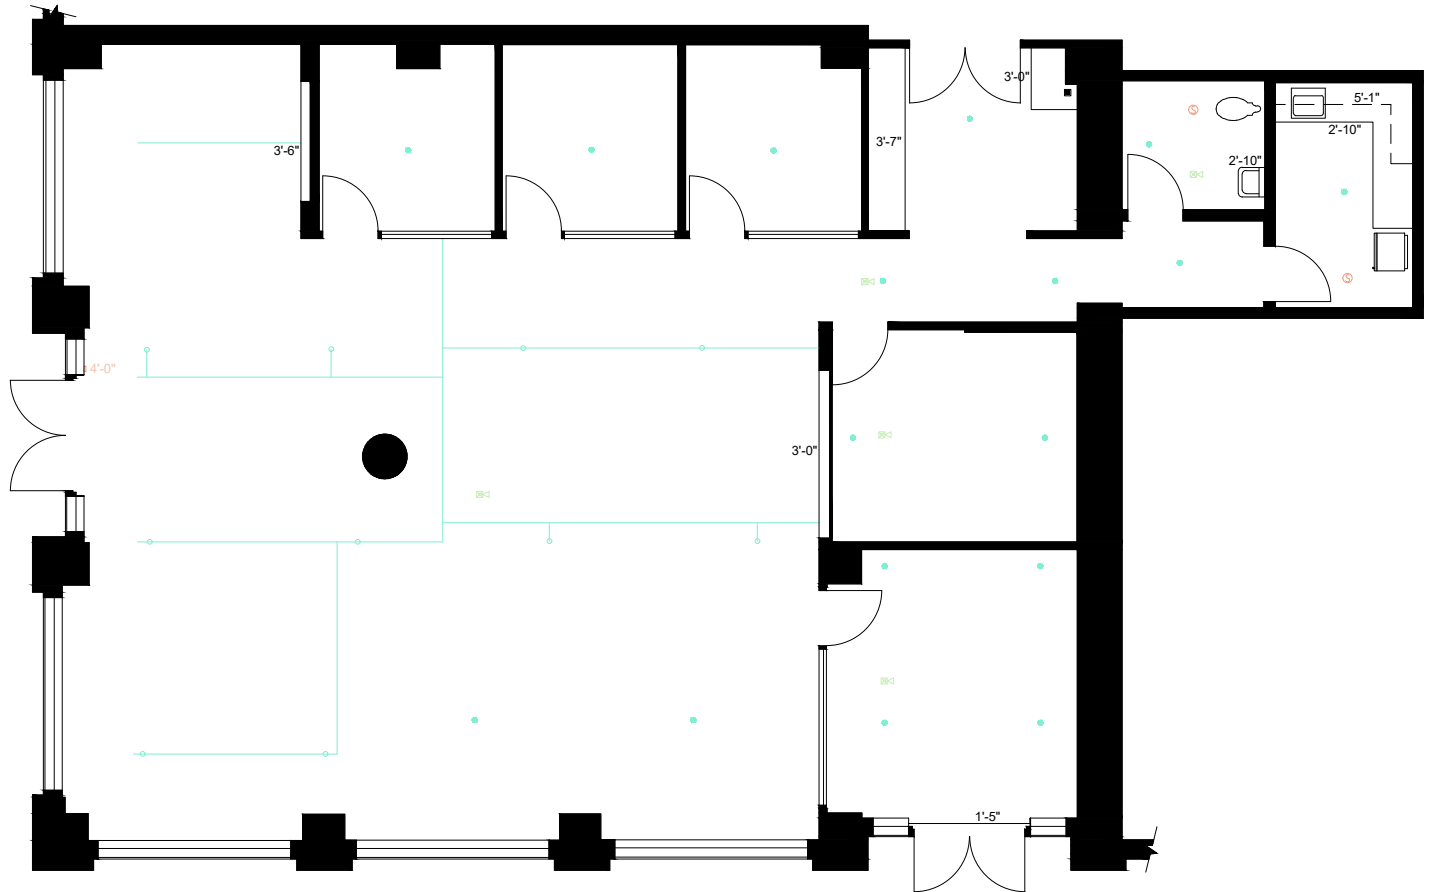

	<b>YOU ARE HERE</b>		<b>ELEVATOR</b>		<b>FIRE HOSE CAB</b>
	<b>STAIRWAY</b>		<b>FIRE EXTINGUISHER</b>		<b>PULL BOX</b>
	<b>EXIT ROUTES</b>		<b>PERSONS WITH DISABILITIES SHALL CALL 911 TO REPORT THEIR LOCATION &amp; PROCEED TO NEAREST STAIRWELL &amp; AWAIT ASSISTANCE. ALL ALARMS - BELL SOUND</b>		



**IN CASE OF FIRE  
DO NOT USE  
ELEVATOR  
USE STAIRS**



**LASERTECH®** is a registered US trademark of Lasertech® Floorplans Ltd.  
 Copyright 1998 Lasertech® Floorplans Ltd., All Rights Reserved